



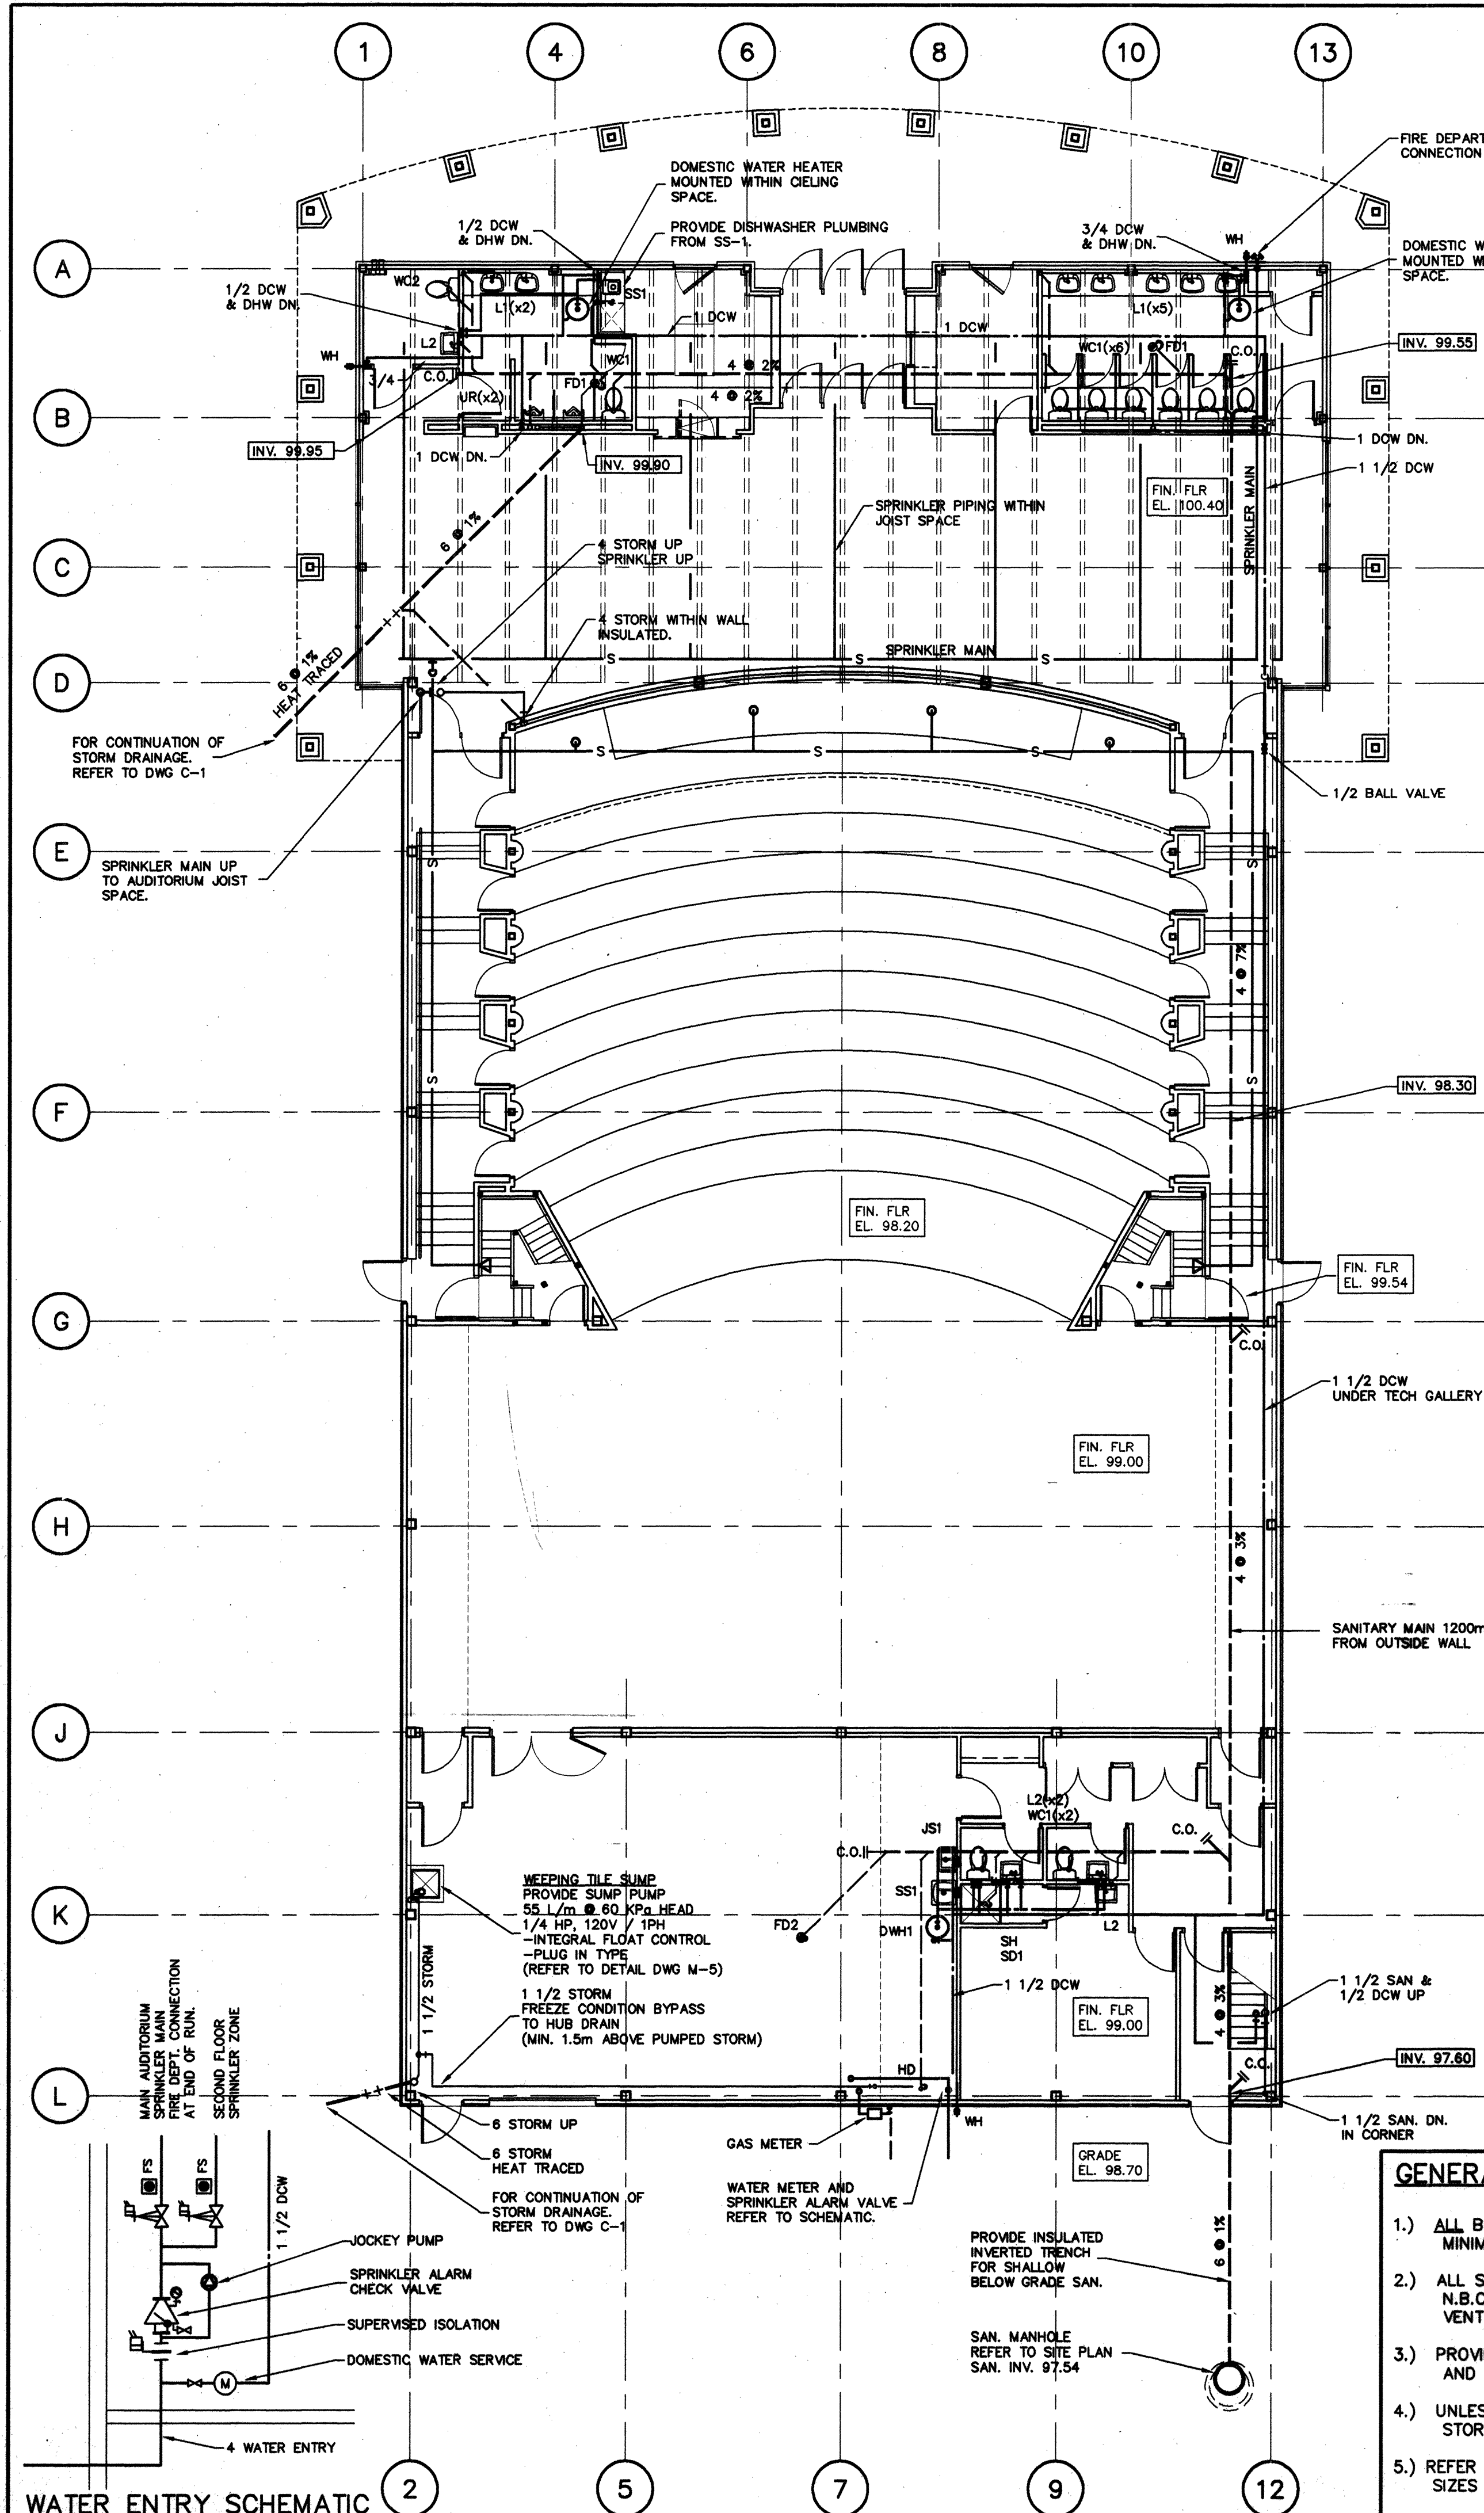

WATER ENTRY SCHEMATIC

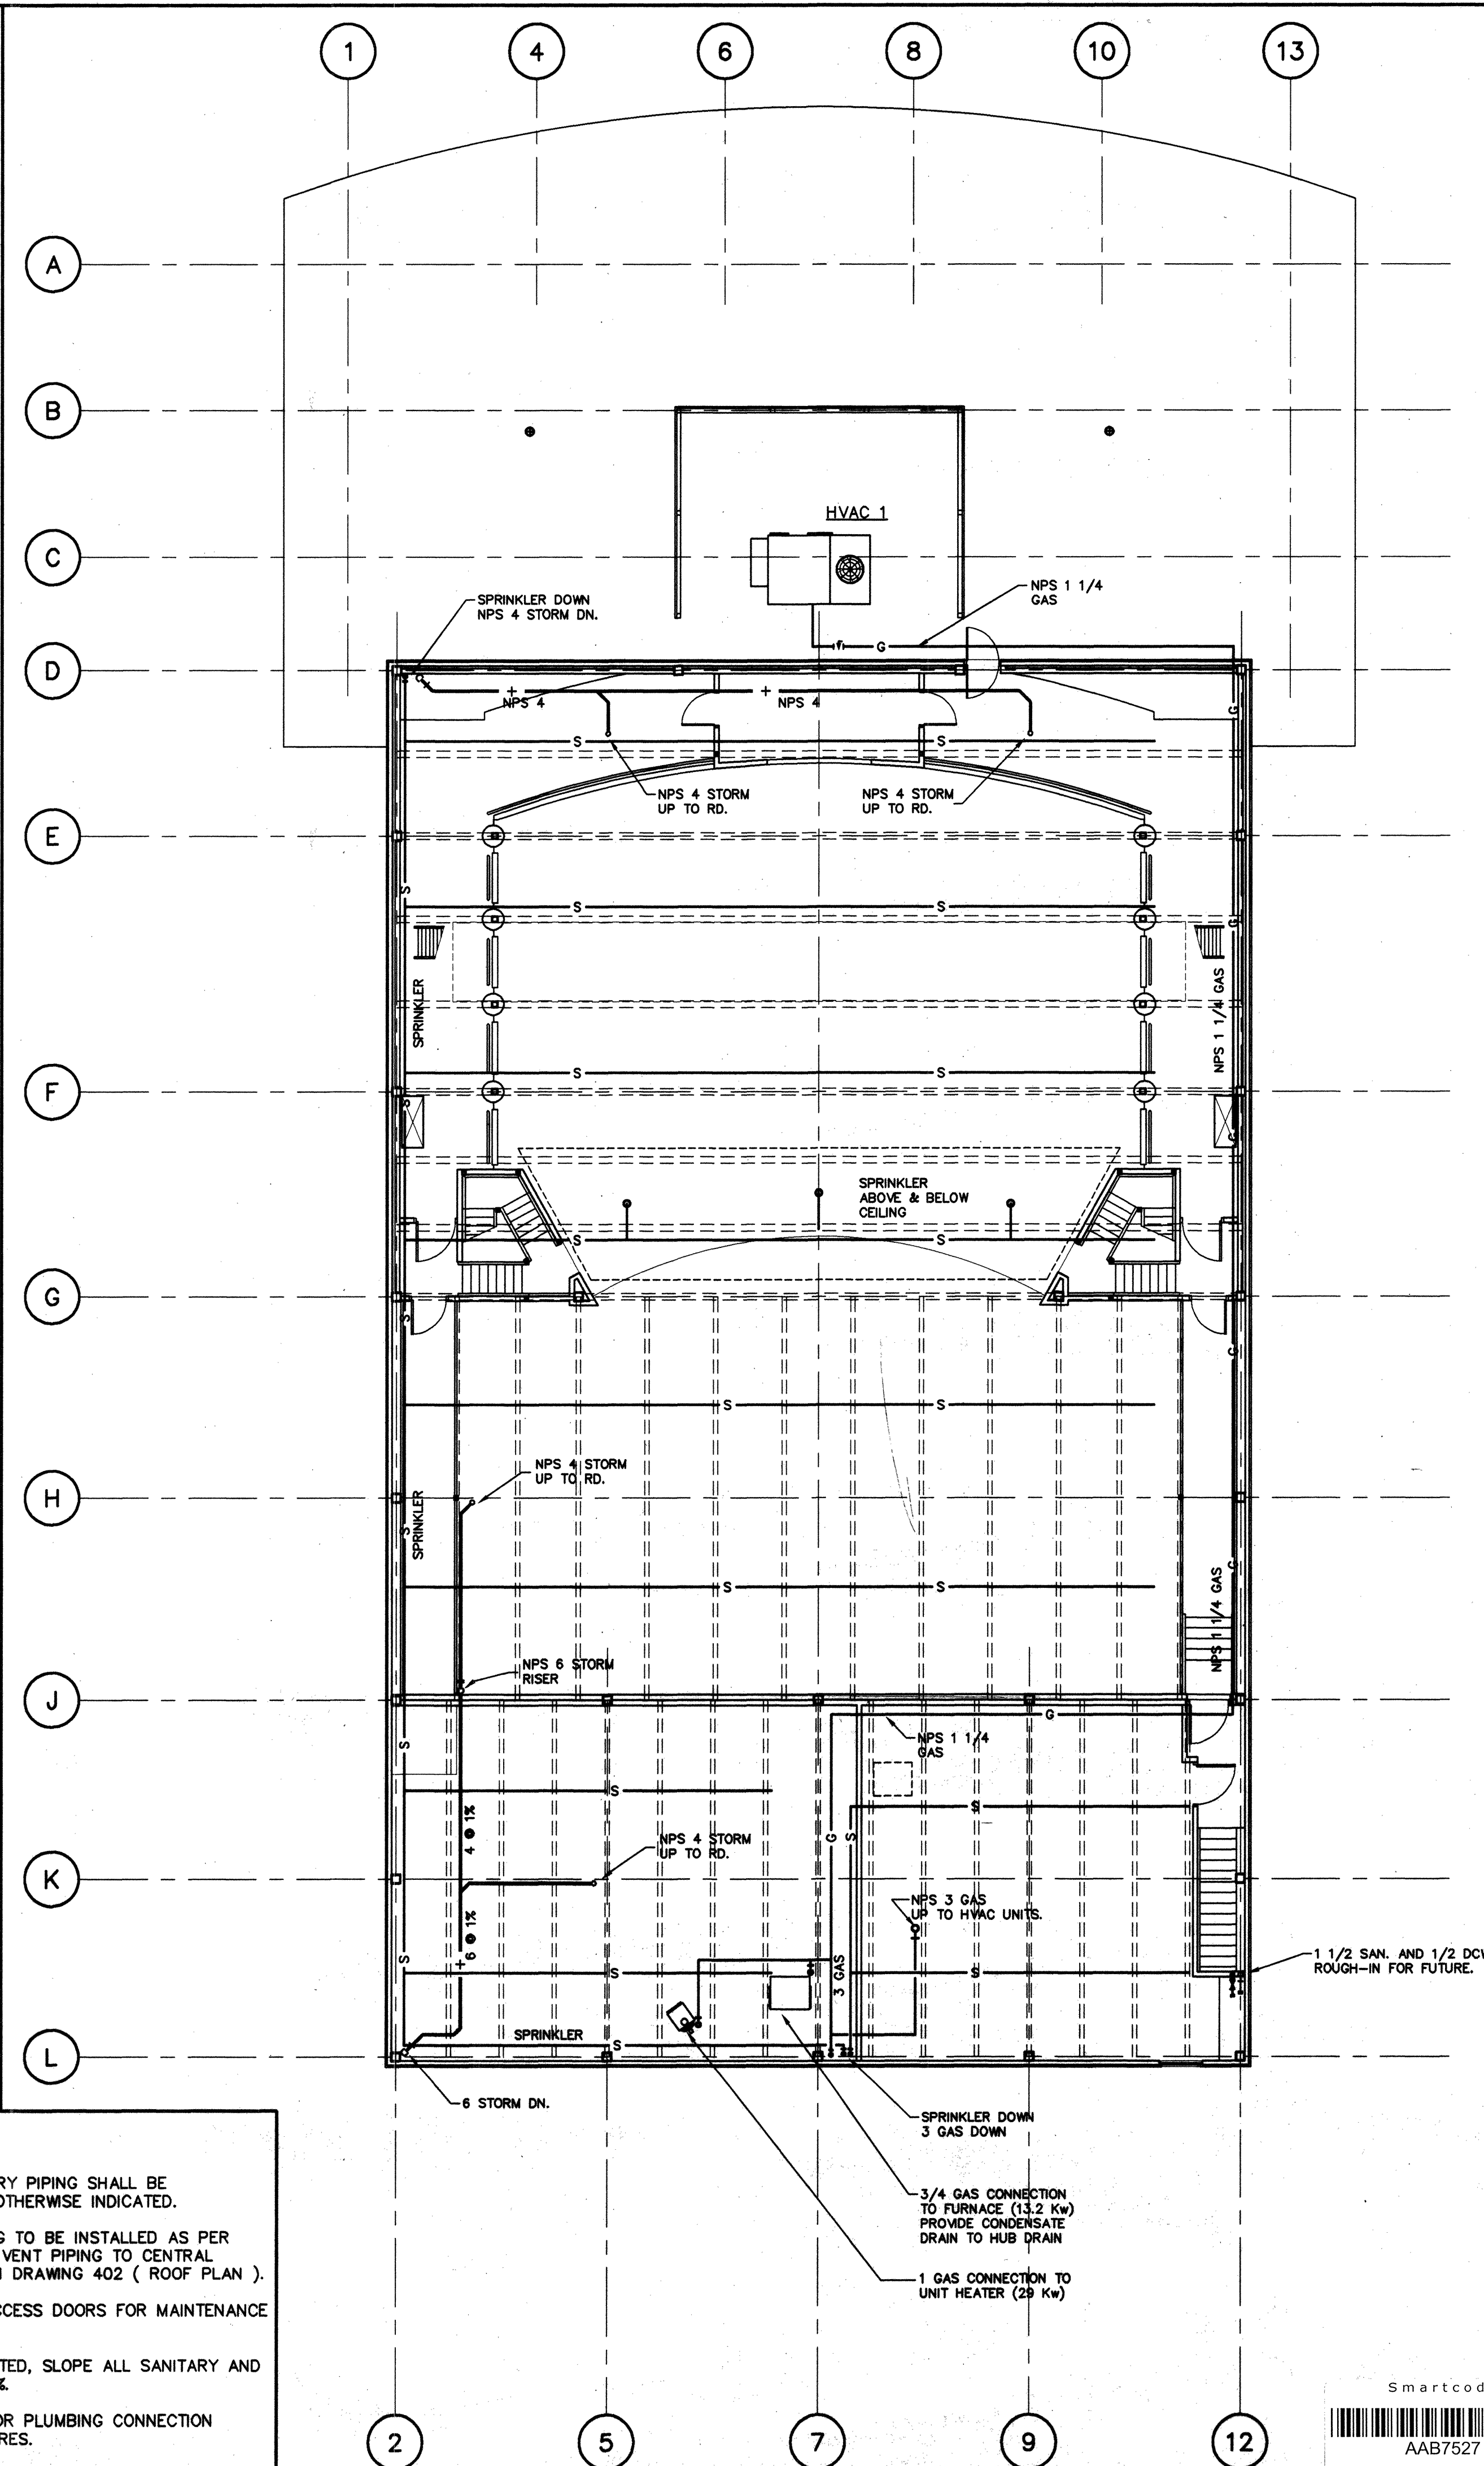

GENERAL NOTES:

1. ALL BELOW GRADE SANITARY PIPING SHALL BE MINIMUM NPS 4 UNLESS OTHERWISE INDICATED.
2. ALL SANITARY VENT PIPING TO BE INSTALLED AS PER N.B.C. PART 7. PIPE ALL VENT PIPING TO CENTRAL VENT RISERS LOCATED ON DRAWING 402 (ROOF PLAN).
3. PROVIDE ALL REQUIRED ACCESS DOORS FOR MAINTENANCE AND SERVICE.
4. UNLESS OTHERWISE INDICATED, SLOPE ALL SANITARY AND STORM PIPING MINIMUM 1%.
5. REFER TO DRAWING M-5 FOR PLUMBING CONNECTION SIZES TO INDIVIDUAL FIXTURES.

RECORD DRAWING

PRODUCED FROM INFORMATION PROVIDED BY CONTRACTOR. DRAWINGS ARE DIAGNOSTIC. FIELD VERIFICATION IS REQUIRED.
date: MAR., 01, 96 P.G.
J.L. RICHARDS & ASSOCIATES LIMITED

NO.	REVISION	DATE
1	ISSUED FOR TENDER	15/5/95
	ISSUE	DATE

J.L. Richards & Associates Limited
Consulting Engineers, Architects & Planners
884 LADY ELLEN PLACE, OTTAWA, CANADA K1Z 5M2
Lett/Smith Architects - Design Consultants

PROJECT: **CITY OF KANATA
THE
RON MASLIN
PLAYHOUSE
Kanata, Ontario**

DRAWING: **MECHANICAL
PLUMBING**

DESIGN: R. SNOW	REVISION NO.:
DRAWN:	DRAWING NO.:
CHECKED: R. SNOW	M2 of 5
DATE: MAY 1995	JOB NO.:
SCALE: 1:100	14456

