

AIR HANDLING UNIT SCHEDULE

[illegible]

PLUMBING FIXTURE SCHEDULE

[illegible]

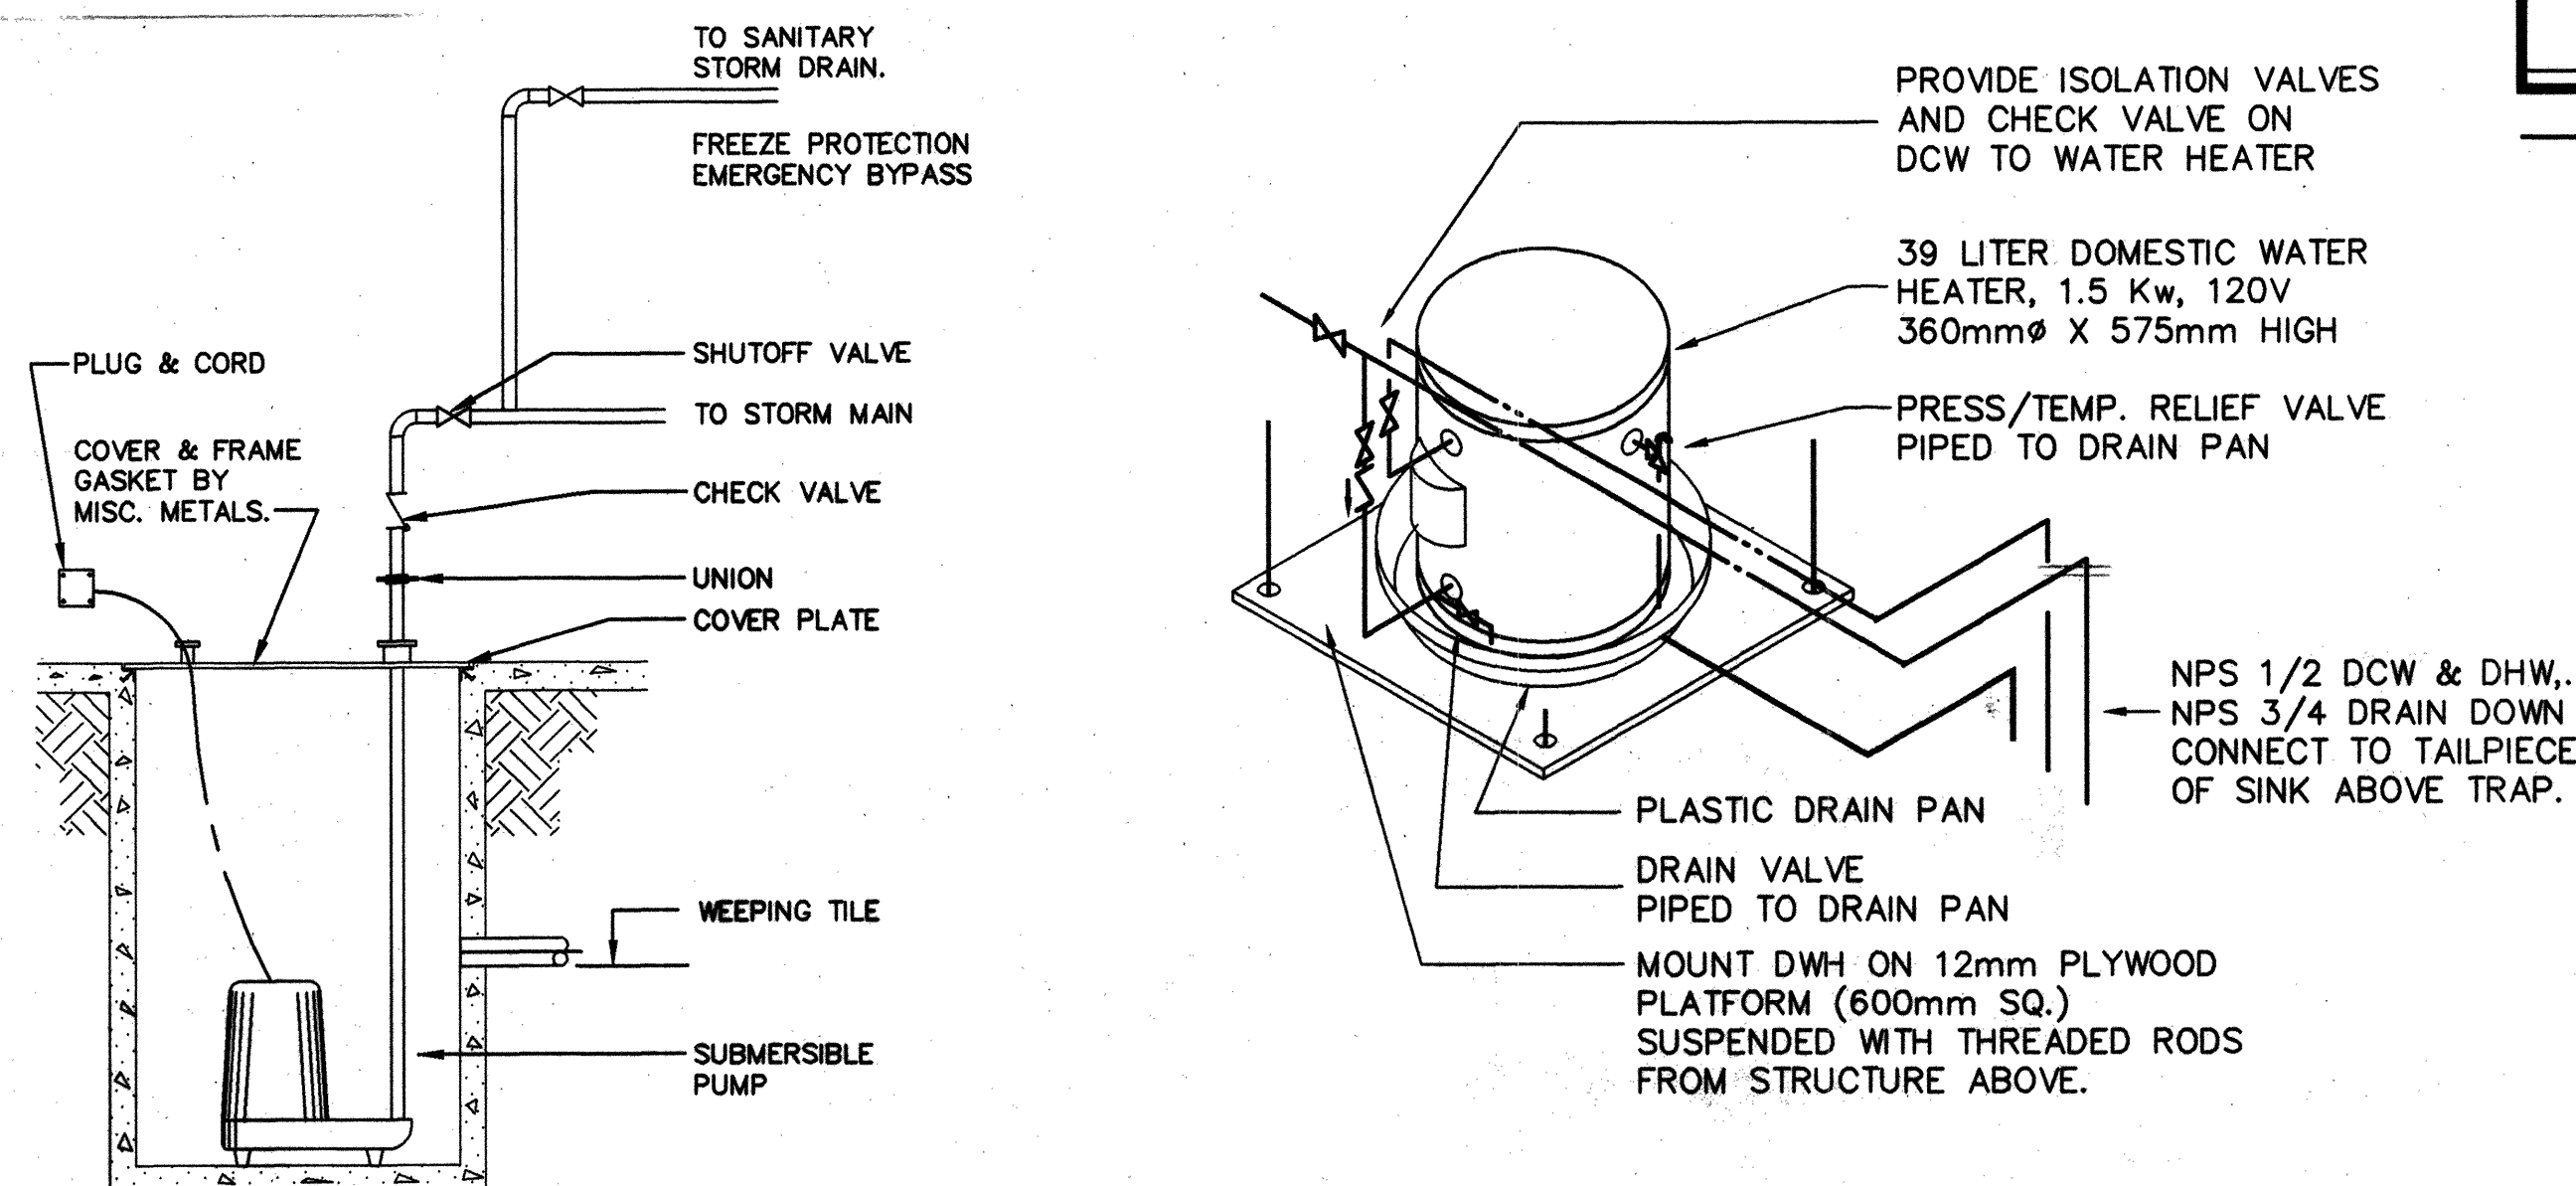
SILENCER SCHEDULE

[illegible]

GRILLE & DIFFUSER SCHEDULE

TYPE	SERVICE			LOCATION	DESCRIPTION	FINISH & ACCESSORIES
	SA	RA	EA			
A	●			WALL / CEILING MOUNTED	STEEL, ADJUSTABLE DOUBLE DEFLECTION 32mm FLAT BORDER CONCEALED FASTENING	OFF-WHITE BAKED ENAMEL OPPOSED BLADE BALANCING DAMPER
B		●	●	CEILING MOUNTED	ALUMINUM, FIXED 0° GRID SPACED @ 13mm 32mm FLAT BORDER CONCEALED FASTENING	ALUMINIUM BAKED ENAMEL OPPOSED BLADE BALANCING DAMPER
C		●	●	WALL MOUNTED	STEEL, FIXED BLADES SPACED @ 13mm 32mm FLAT BORDER	PRIME PAINTED
D		●		WALL MOUNTED	LINEAR BAR GRILLE SPACED @ 13mm 20mm FLAT BORDER	PRIME PAINTED

FAN SCHEDULE

[illegible]

WEeping TILE SUMP DETAIL
N.T.S.

**TYPICAL CEILING MOUNTED
DOMESTIC WATER HEATER**

RECORD DRAWING	
PRODUCED FROM INFORMATION PROVIDED BY CONTRACTOR. DRAWINGS ARE DIAGRAMATIC. FIELD VERIFICATION IS REQUIRED.	
date:	MAR., 01, 96 P.G.
J.L. RICHARDS & ASSOCIATES LIMITED	

NO.	REVISION	DATE
1	ISSUED FOR TENDER	15/4/95
NO.	ISSUE	DATE

 **J.L. Richards & Associates Limited**
Consulting Engineers, Architects & Planners
864 LADY ELLEN PLACE, OTTAWA, CANADA K1Z 5M2

Lett/Smith Architects • Design Consultants

PROJECT: CITY OF KANATA
THE
RON MASLIN
PLAYHOUSE
Kanata, Ontario

MECHANICAL SCHEDULES AND DETAILS

DESIGN: R. SNOW	REVISION NO.:
DRAWN:	DRAWING NO.:
CHECKED: R.SNOW	M5 of 5
DATE: MAY 1995	
SCALE:	JOB NO.: 14456

