




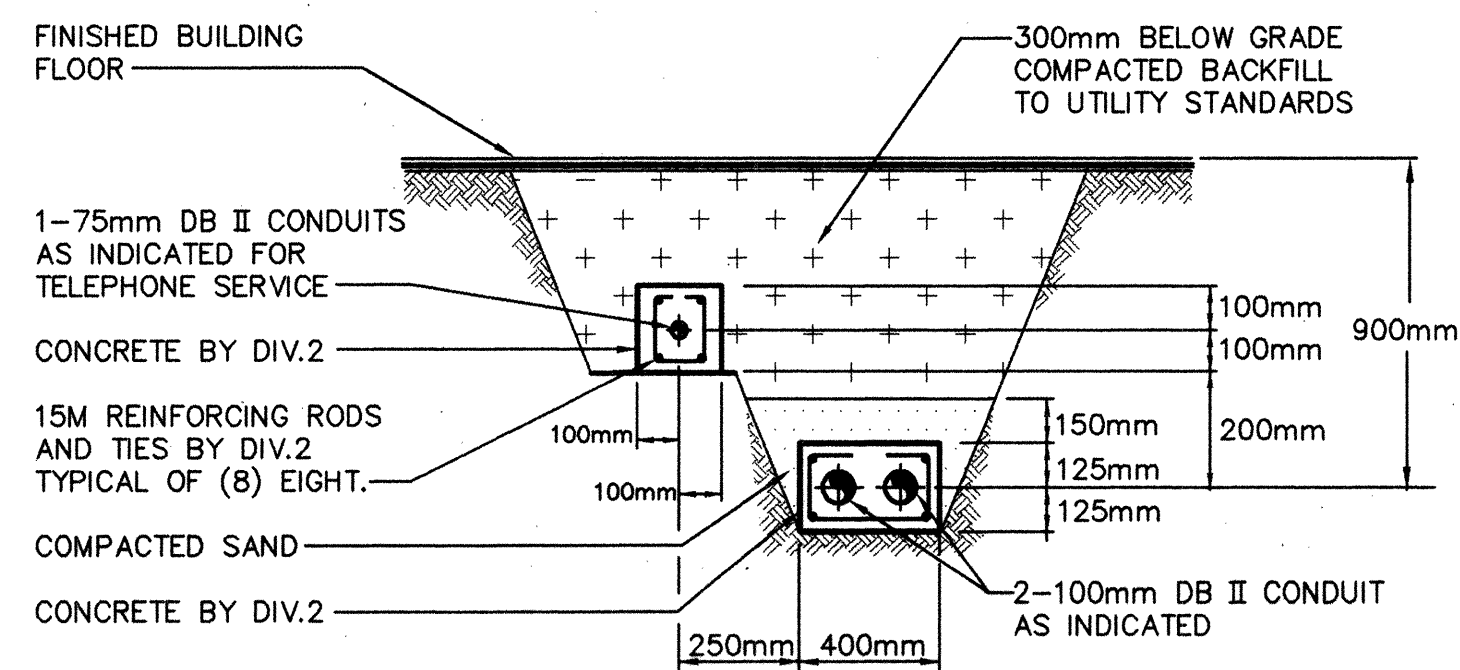

**TYPICAL CONCRETE ENCASED DUCT
SECTION "B-B"**
N.T.S.

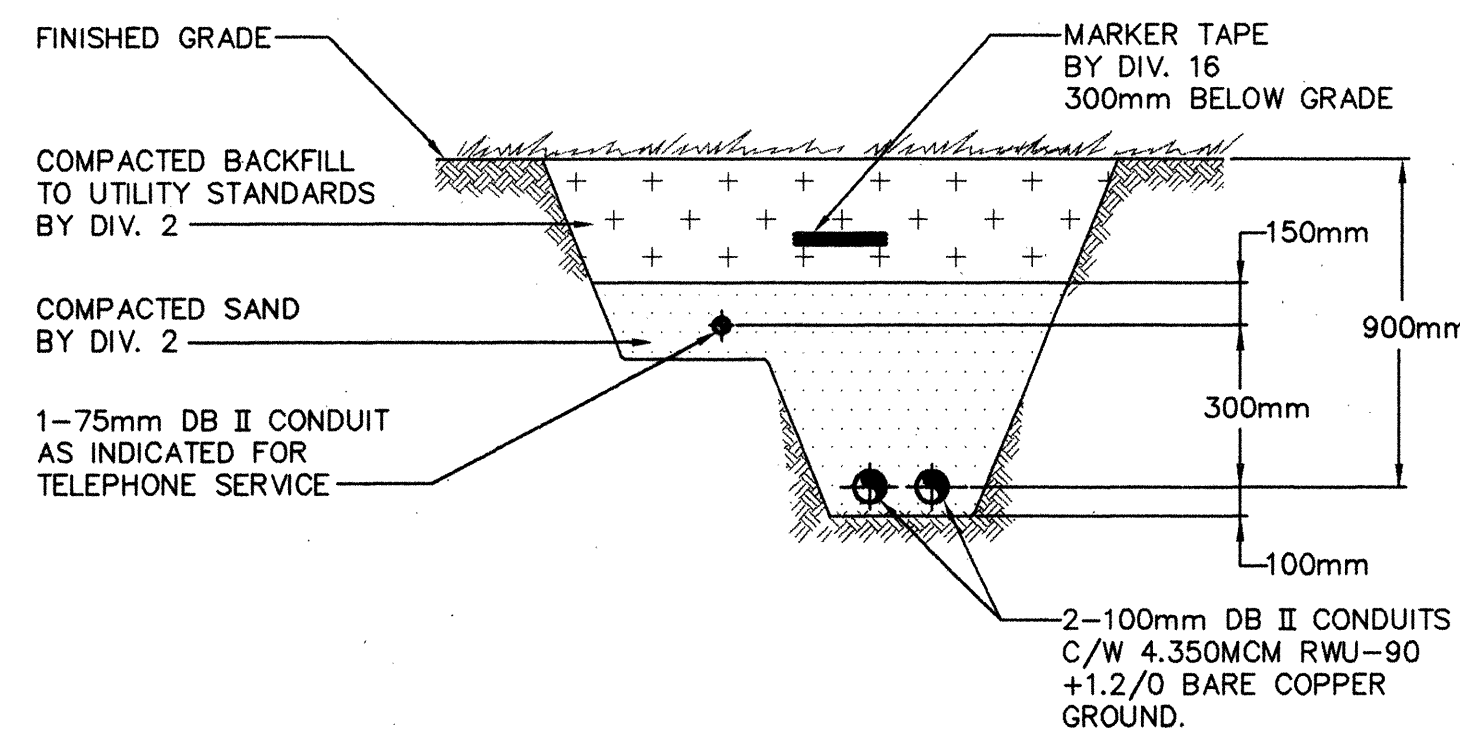

**TYPICAL DIRECT BURIED CONDUIT
SECTION "C-C"**
N.T.S.

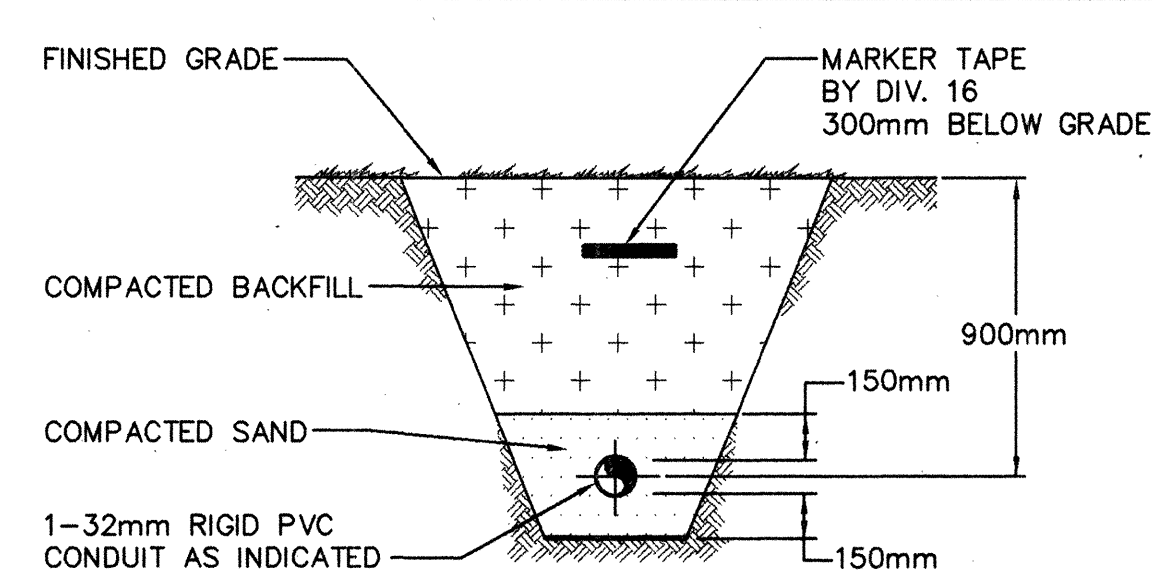


**TRENCH DETAIL UNDERGROUND DUCT
SECTION "A-A"**
N.T.S.

WALTER BAKER PLACE


TERRY FOX DRIVE

IRON MASLIN PLAYHOUSE

KANATA RECREATION COMPLEX

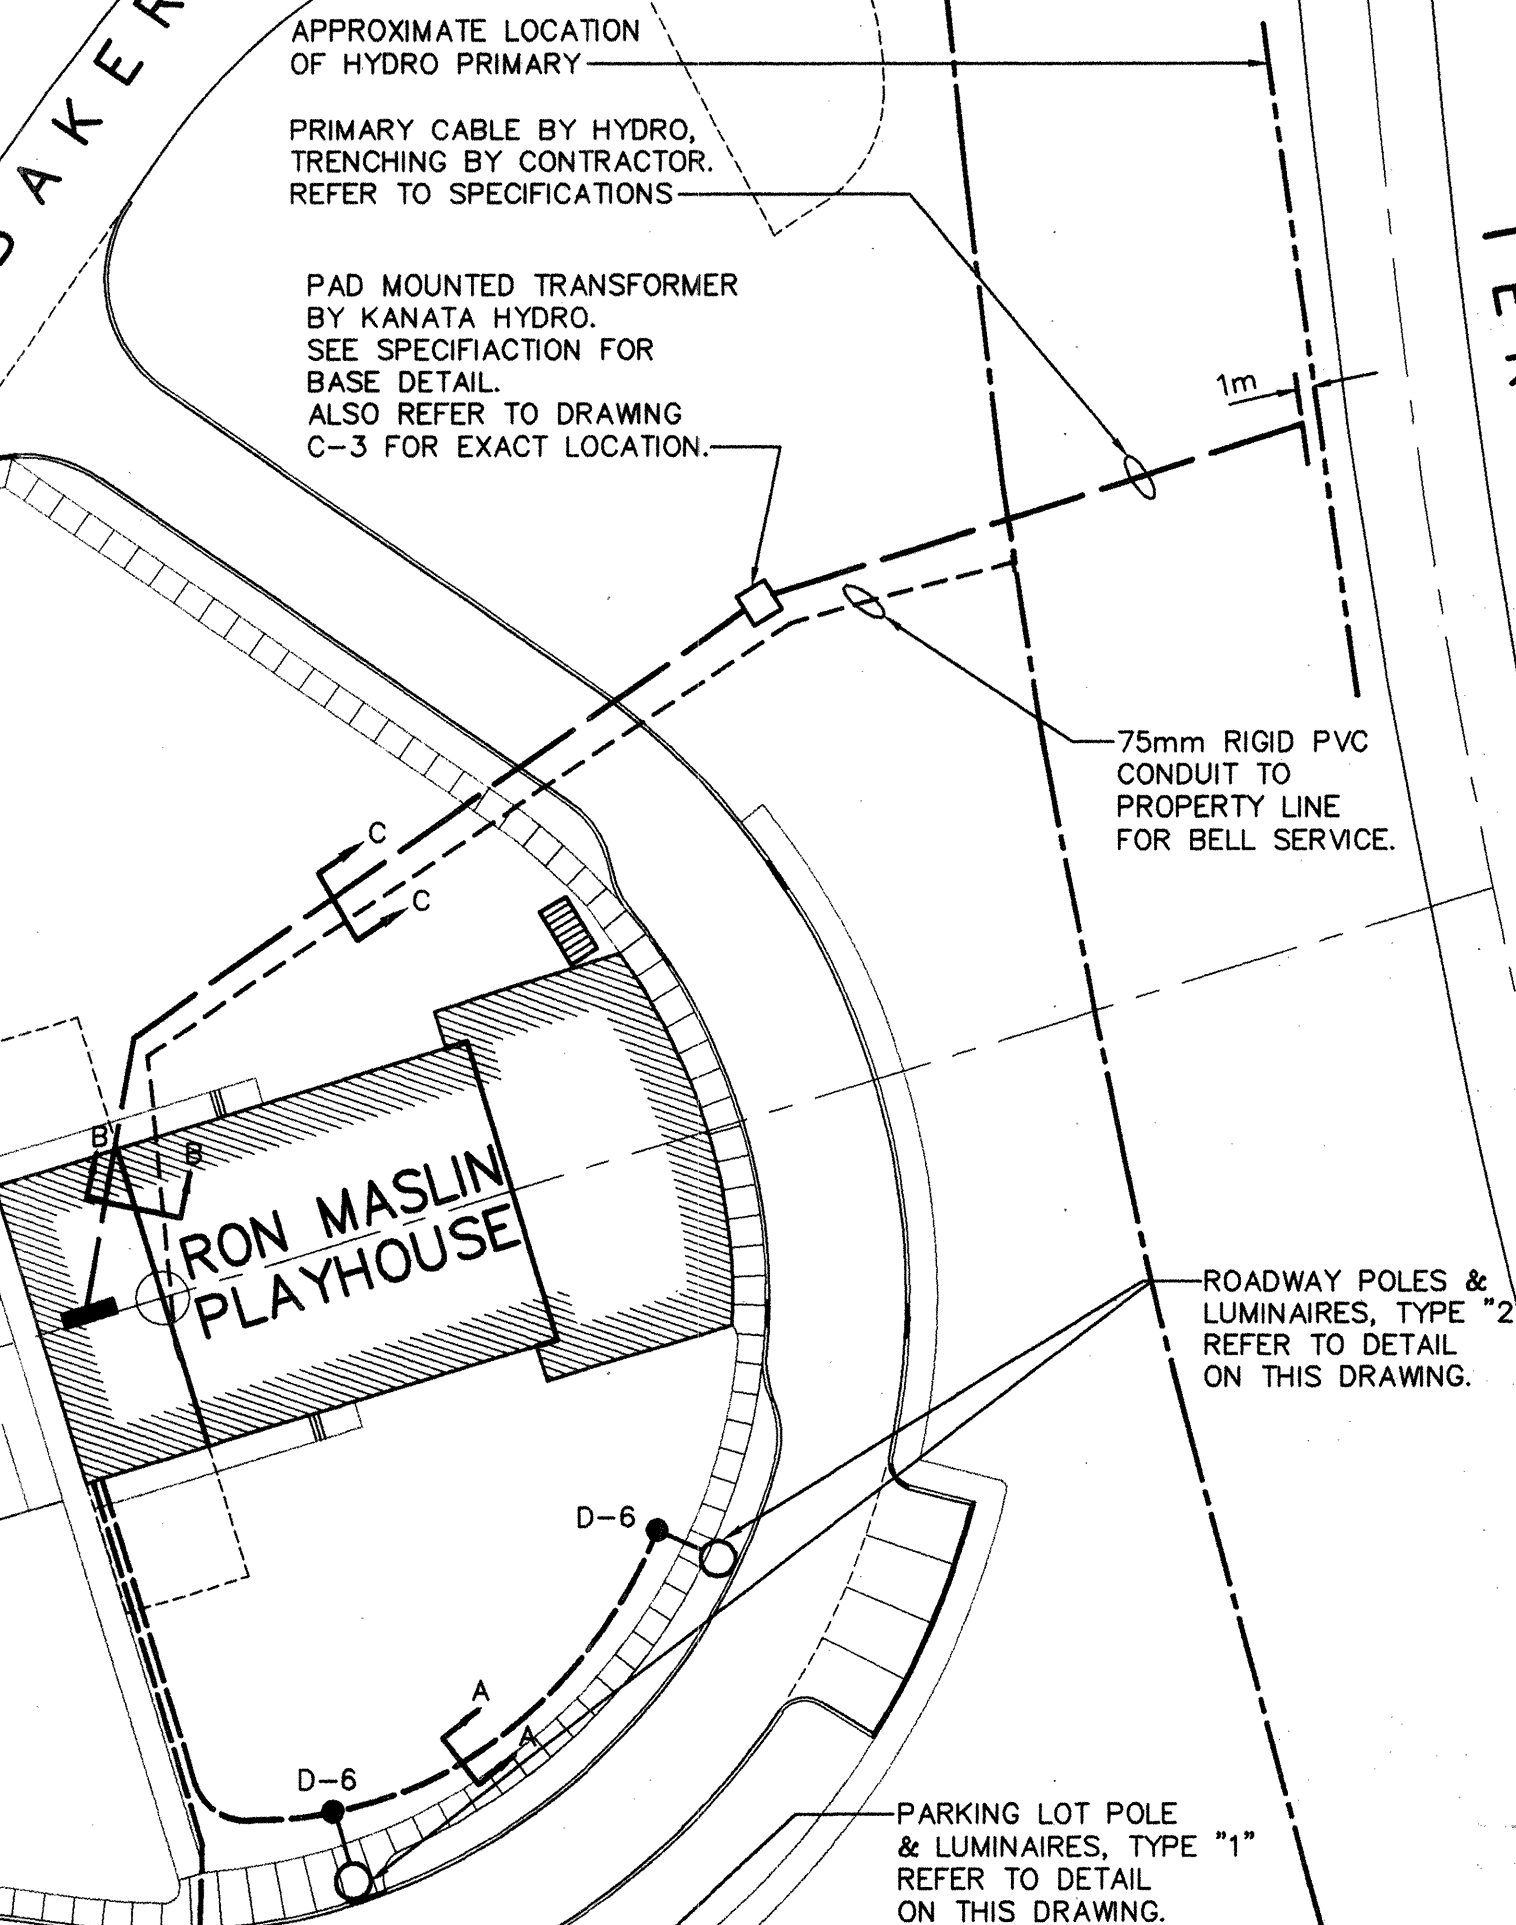


- LEGEND:**
- ⊕ TYPE "F" FIXTURE
 - ⊖ TYPE "G" FLUORESCENT FIXTURE
 - ⊗ TYPE "K" FLUORESCENT FIXTURE
 - ⊙ TYPE "R" RECESSED INCANDESCENT POT LIGHT
 - ⊕⊖ CEILING MOUNTED EMERGENCY FIXTURE TYPE "E2"
 - ⊕⊖ TYPE "H" WALL MOUNTED INCANDESCENT FIXTURE
 - ⊕⊖ WALL MOUNTED EXIT LIGHT
 - ⊕⊖ WALL MOUNTED EMERGENCY LIGHT FIXTURE TYPE "E"
 - ⊕⊖ EMERGENCY BATTERY UNIT, 120V RECEPTACLE (EBU)
 - ⊕ TELEPHONE OUTLET
 - ⊕ PAY PHONE
 - ⊕ TOGGLE SWITCH
 - ⊕ TOGGLE SWITCH, THREE WAY
 - ⊕ TOGGLE SWITCH, FOUR WAY
 - ⊕ RELAY SWITCH
 - ⊕ GANGED TOGGLE SWITCHES
 - ⊕ HANDICAP DOOR SWITCH
 - ⊕ DUPLEX RECEPTACLE
 - ⊕ DUPLEX RECEPTACLE, 120V 15A, GROUND FAULT
 - ⊕ SPLIT CIRCUIT DUPLEX RECEPTACLE 120V, 15A
 - ⊕ FIRE ALARM PULL STATION
 - ⊕ FIRE ALARM BELL
 - ⊕ FIRE ALARM PULL STATION AND BELL
 - ⊕ SMOKE DETECTOR
 - ⊕ THERMOSTAT
 - ⊕ PRESSURE SWITCH BY DIV. 15; WIRED BY DIV. 16
 - ⊕ TIME SWITCH
 - ⊕ FLOW SWITCH BY DIV. 15; WIRED BY DIV. 16
 - ⊕ TAMPER SWITCH BY DIV. 15; WIRED BY DIV. 16
 - ⊕ MANUAL MOTOR STARTER
 - ⊕ DISCONNECT SWITCH
 - ⊕ SINGLE PHASE MOTOR, 1/4 H.P. VOLTAGE AS INDICATED
 - ⊕ OVER COUNTER
 - ⊕ UNDER COUNTER
 - ⊕ SEB SERVICE ENTRANCE BOARD

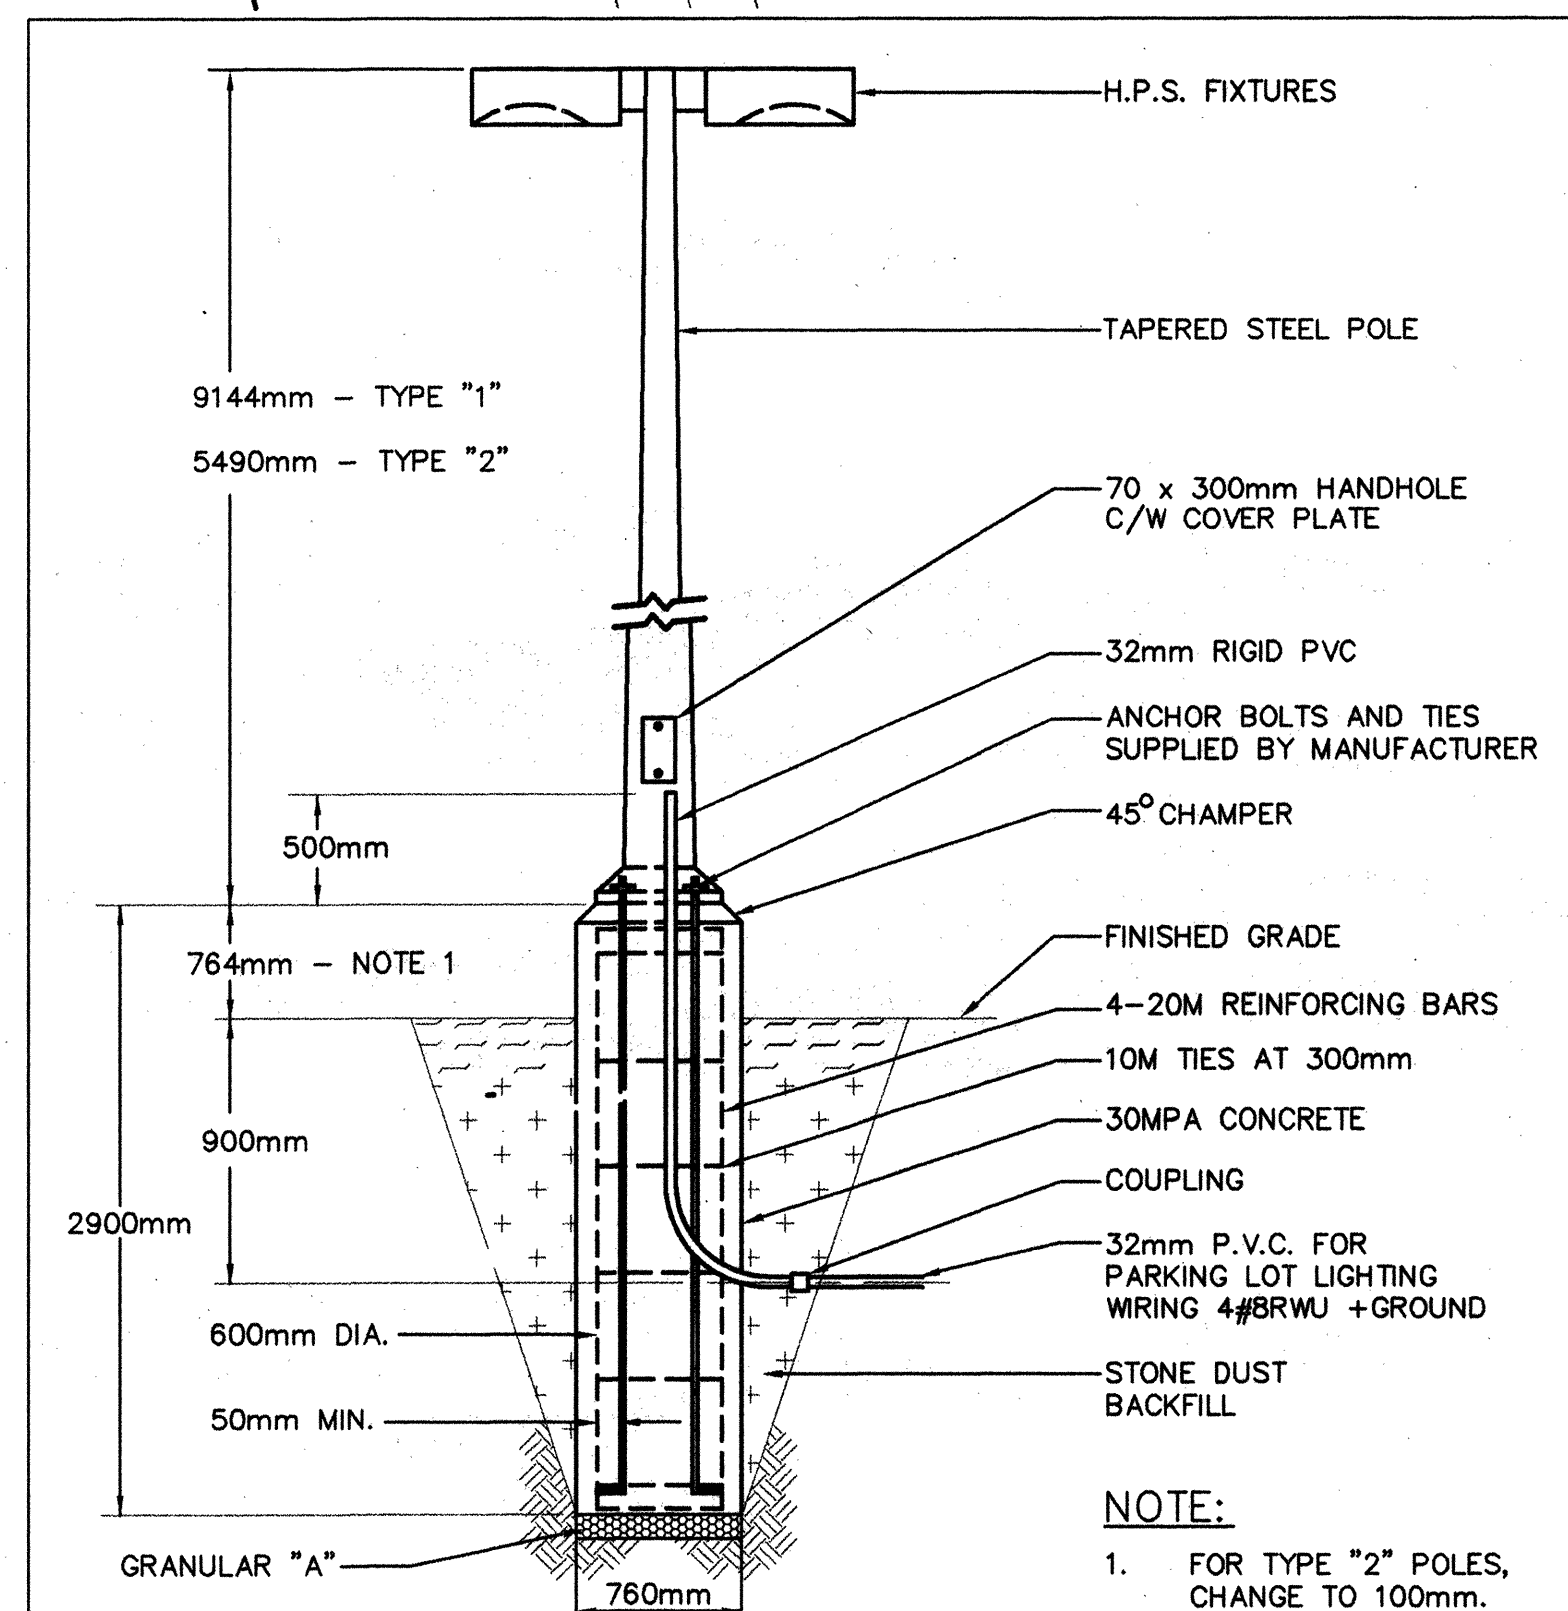

PARKING LOT LIGHTING STANDARD
N.T.S.

RECORD DRAWING
PRODUCED FROM INFORMATION
PROVIDED BY CONTRACTOR.
DATE FEB. 29, 1996
J.L.RICHARDS & ASSOCIATES LIMITED

NO.	REVISION	DATE
1	ISSUED FOR TENDER	15/5/95
NO.	ISSUE	DATE

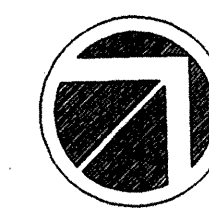

Smartcode
AAB7531

J.L. Richards & Associates Limited
Consulting Engineers, Architects & Planners
884 LADY ELLEN PLACE, OTTAWA, CANADA K1Z 5M2
Lett/Smith Architects - Design Consultants

PROJECT: **CITY OF KANATA
THE
RON MASLIN
PLAYHOUSE
Kanata, Ontario**

DRAWING: **ELECTRICAL
SITE PLAN
AND LEGEND**

DESIGN: W.F.F.	REVISION NO.:
DRAWN: M.N.	DRAWING NO.:
CHECKED: W.F.F.	E-1
DATE: FEBRUARY 1995	JOB NO.: 14456
SCALE: 1 : 500	